


Industrial Rd.

SITE LAYOUT
SCALE - 1:400

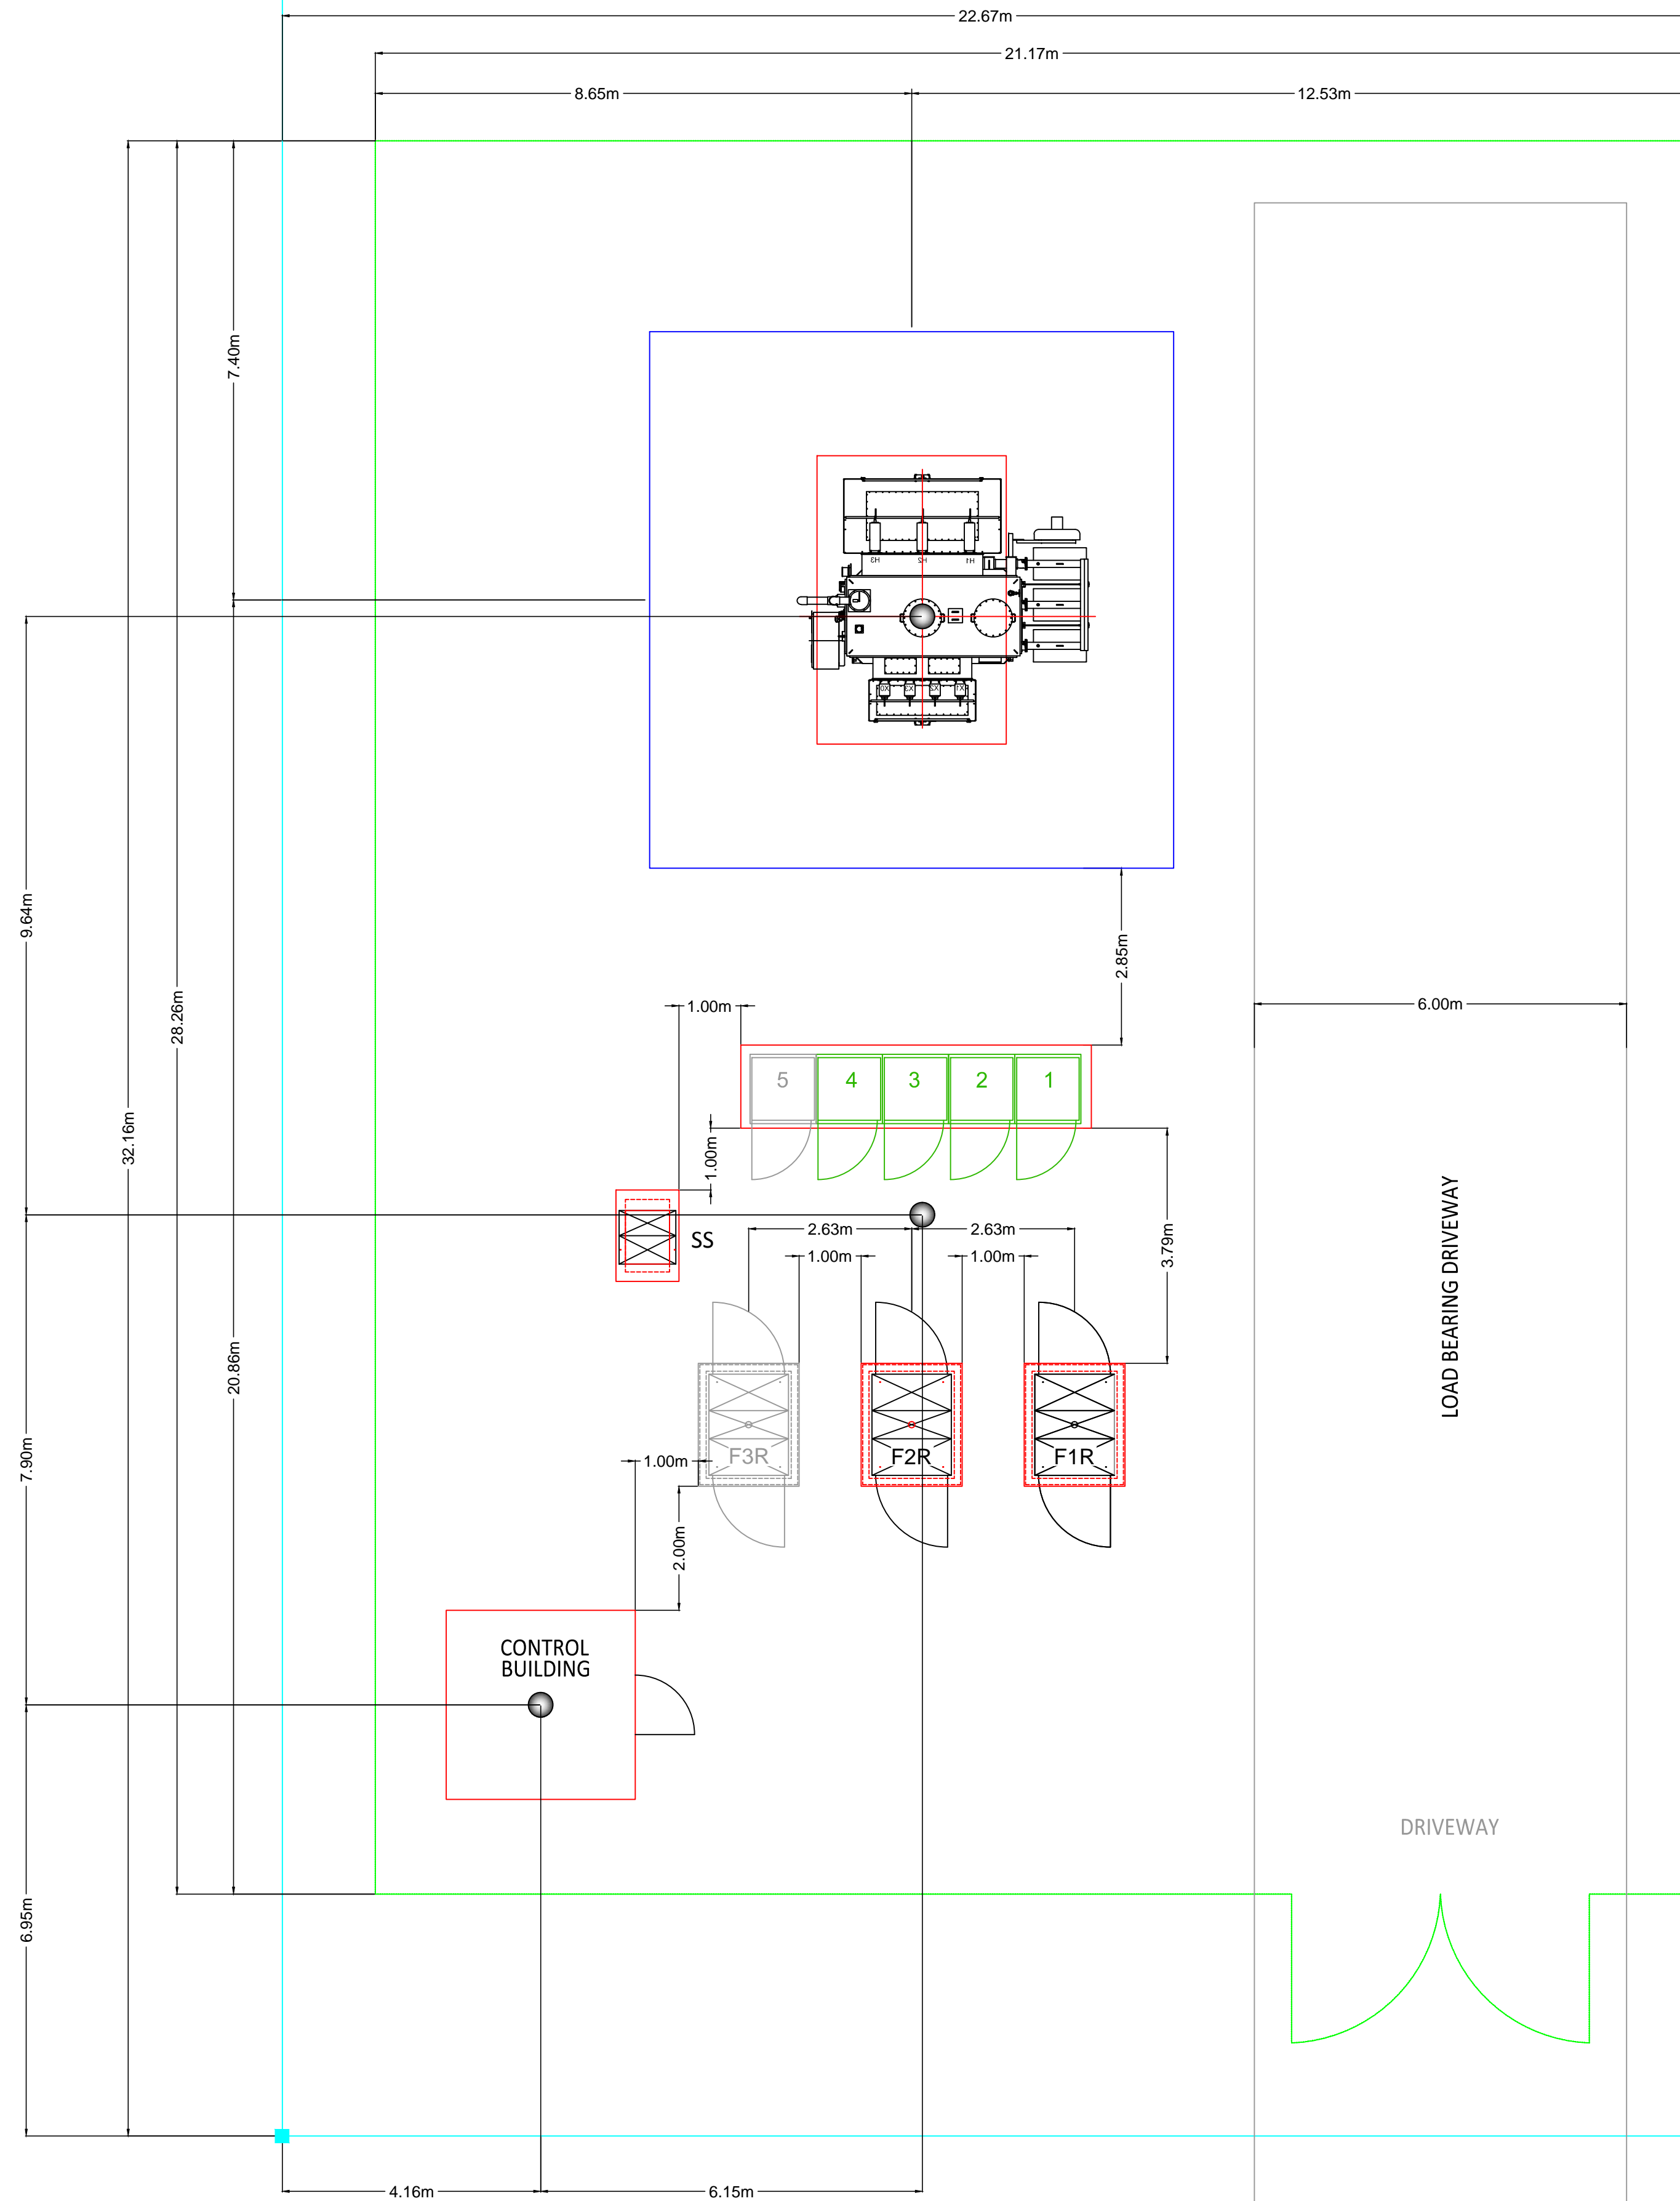

PROPOSED STATION LAYOUT
SCALE - 1:75

LEGEND:

- PROPERTY LINE
- FENCE LINE
- BOREHOLE LOCATION
- PROPERTY BAR



FOR CUSTOMER REVIEW

DISCLAIMER
THIS DOCUMENT WAS PREPARED AND PROVIDED PURSUANT TO A CONTRACT WITH CUSTOMER AND/OR END USER THAT DEFINES THE PARTIES RESPECTIVE RIGHTS TO WORK PRODUCT AND INTELLECTUAL PROPERTY. ANY OTHER USE OF THIS DOCUMENT IS PROHIBITED. ALL OTHER RIGHTS ARE RESERVED AND NO LICENSE OR RIGHTS TO THE SUBJECT MATTER OF THIS DOCUMENT ARE GRANTED BY POSSESSION THEREOF.

Rev. No.	Revision	Date	By	Appr.
0	ISSUED FOR CLIENT REVIEW	03/10/2018	KL	REL

costello
Utility Consultants

Costello Utility Consultants
4096 Meadowbrook Drive, Unit 112
London, Ontario N6L 1G4
Ph: 519-203-1222
www.costelloassociates.ca

Client Contact

Ottawa River Power

283 Pembroke St. W.,
Pembroke, Ontario
K8A 6Y6
Ph: 613-732-3687
www.orpowercorp.com

OTTAWA RIVER POWER

**ALMONTE MS4
ELECTRICAL DRAWINGS
GENERAL ARRANGEMENT - SITE PLAN**

Final Drawing Size: ARCH D (24x36)	Scale: AS NOTED
Drawn by: L.BONSI / K.LAPIER	Date: 03/10/2018
Designed by: R.LAPIER	Date: 03/10/2018
Checked by: R.LAPIER	Date: 03/10/2018
Approved by: R.LAPIER	Date: 03/10/2018
Project Number: 18147	Drawing Number: E-102