




-  Parkway West Project (Union Gas EB-2012-0433)
-  Parkway D Compressor (Union Gas EB-2013-0074)
-  Brantford-Kirkwall Loop (Union Gas EB-2013-0074)
-  GTA Project - Segment A (Enbridge EB-2012-0451)
-  Parkway Extension Project (Union Gas/Gaz Métro)
-  Existing Union Gas
-  Existing TCPL
-  Existing TCPL Domestic (Hamilton) Line

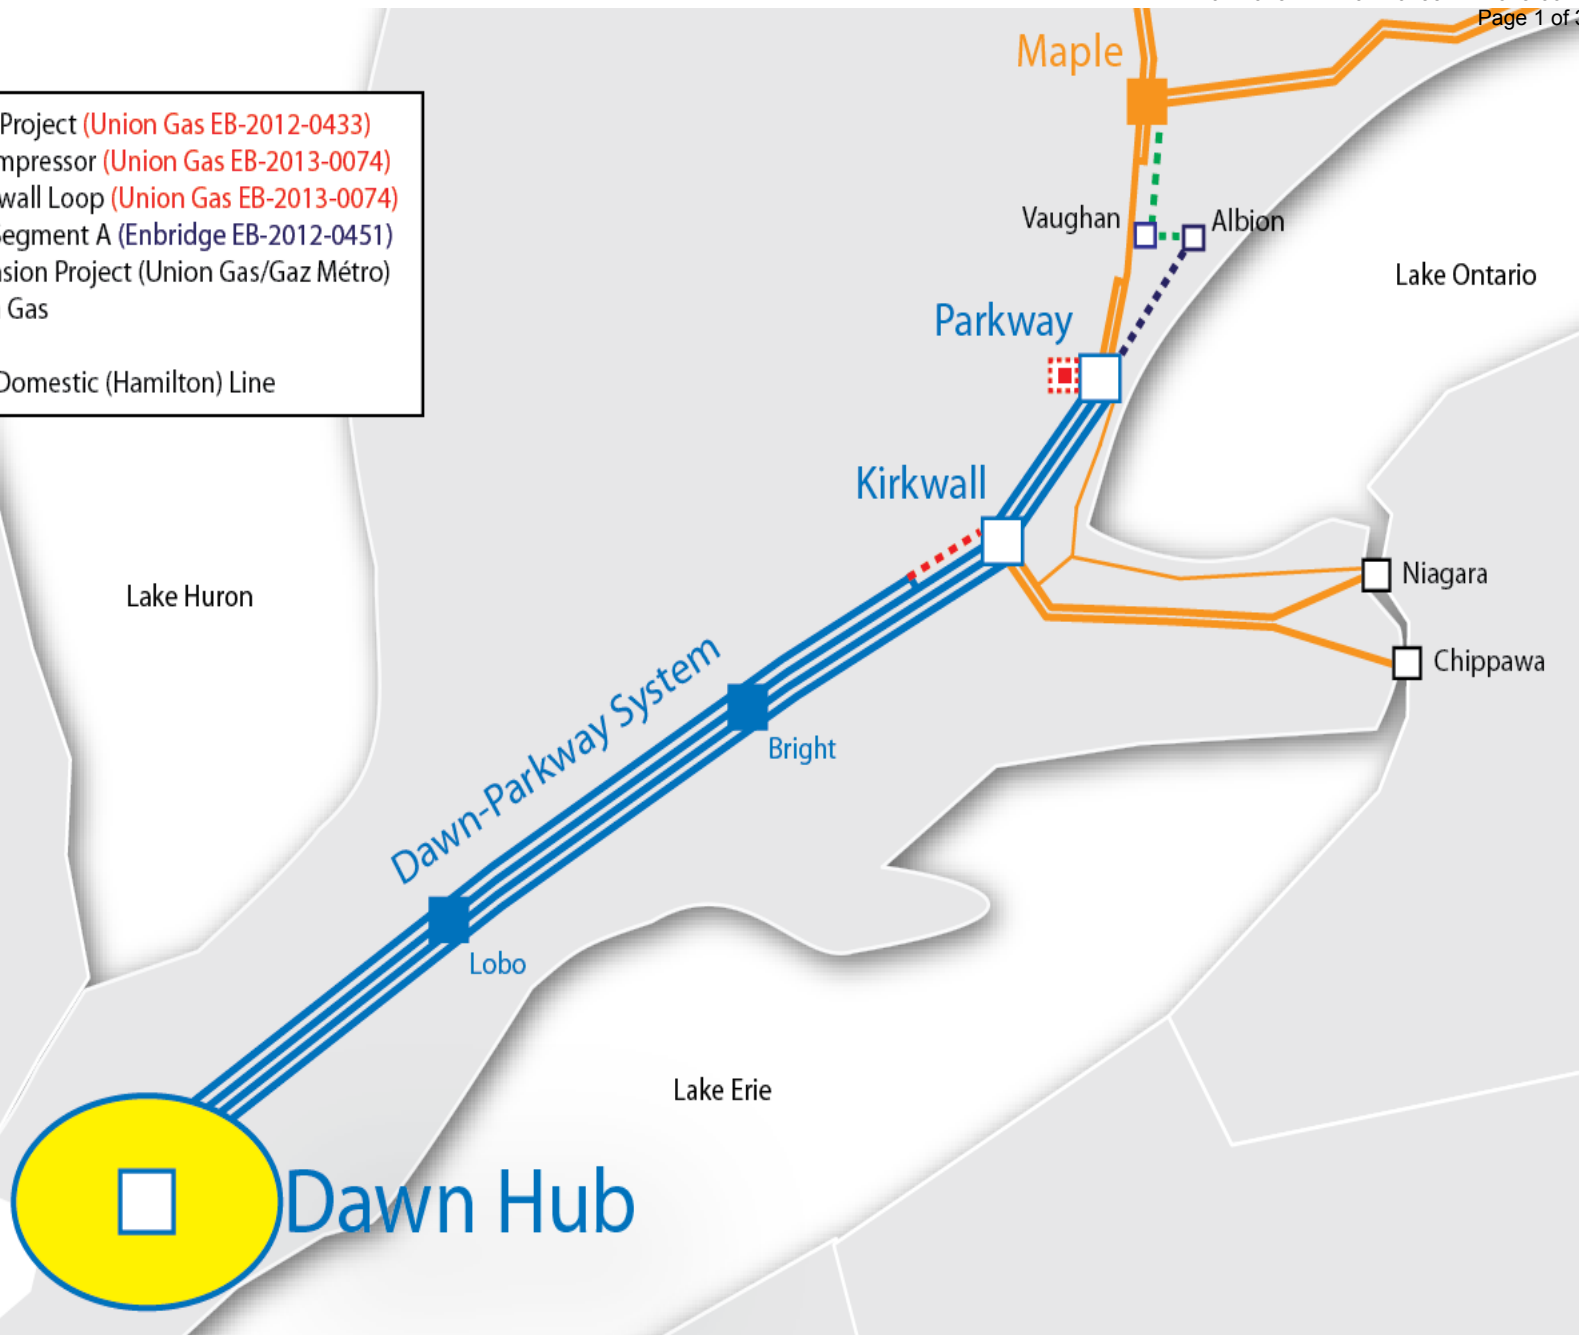

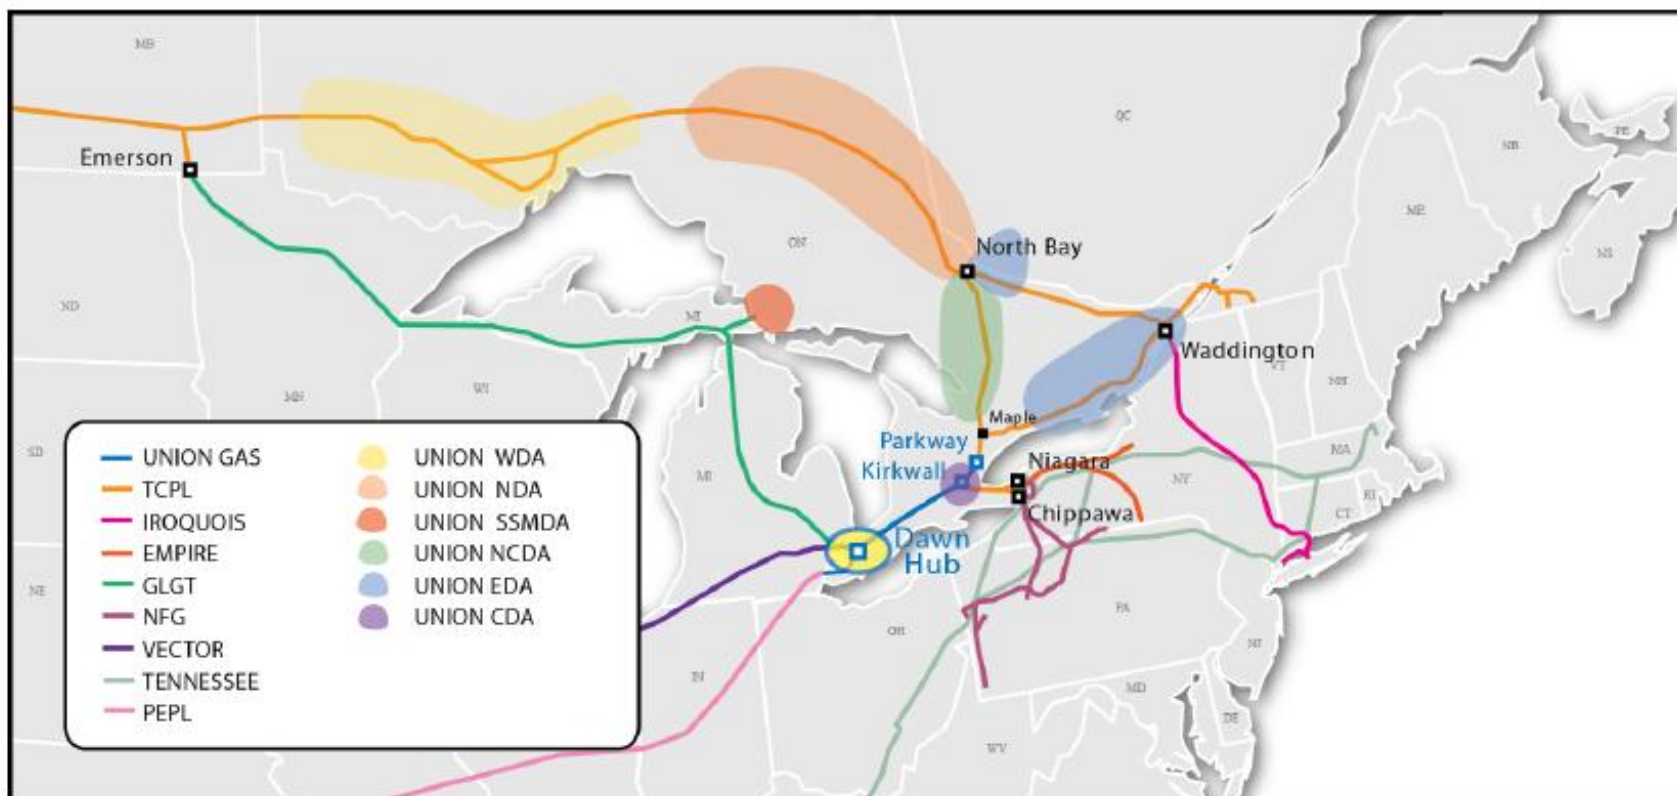

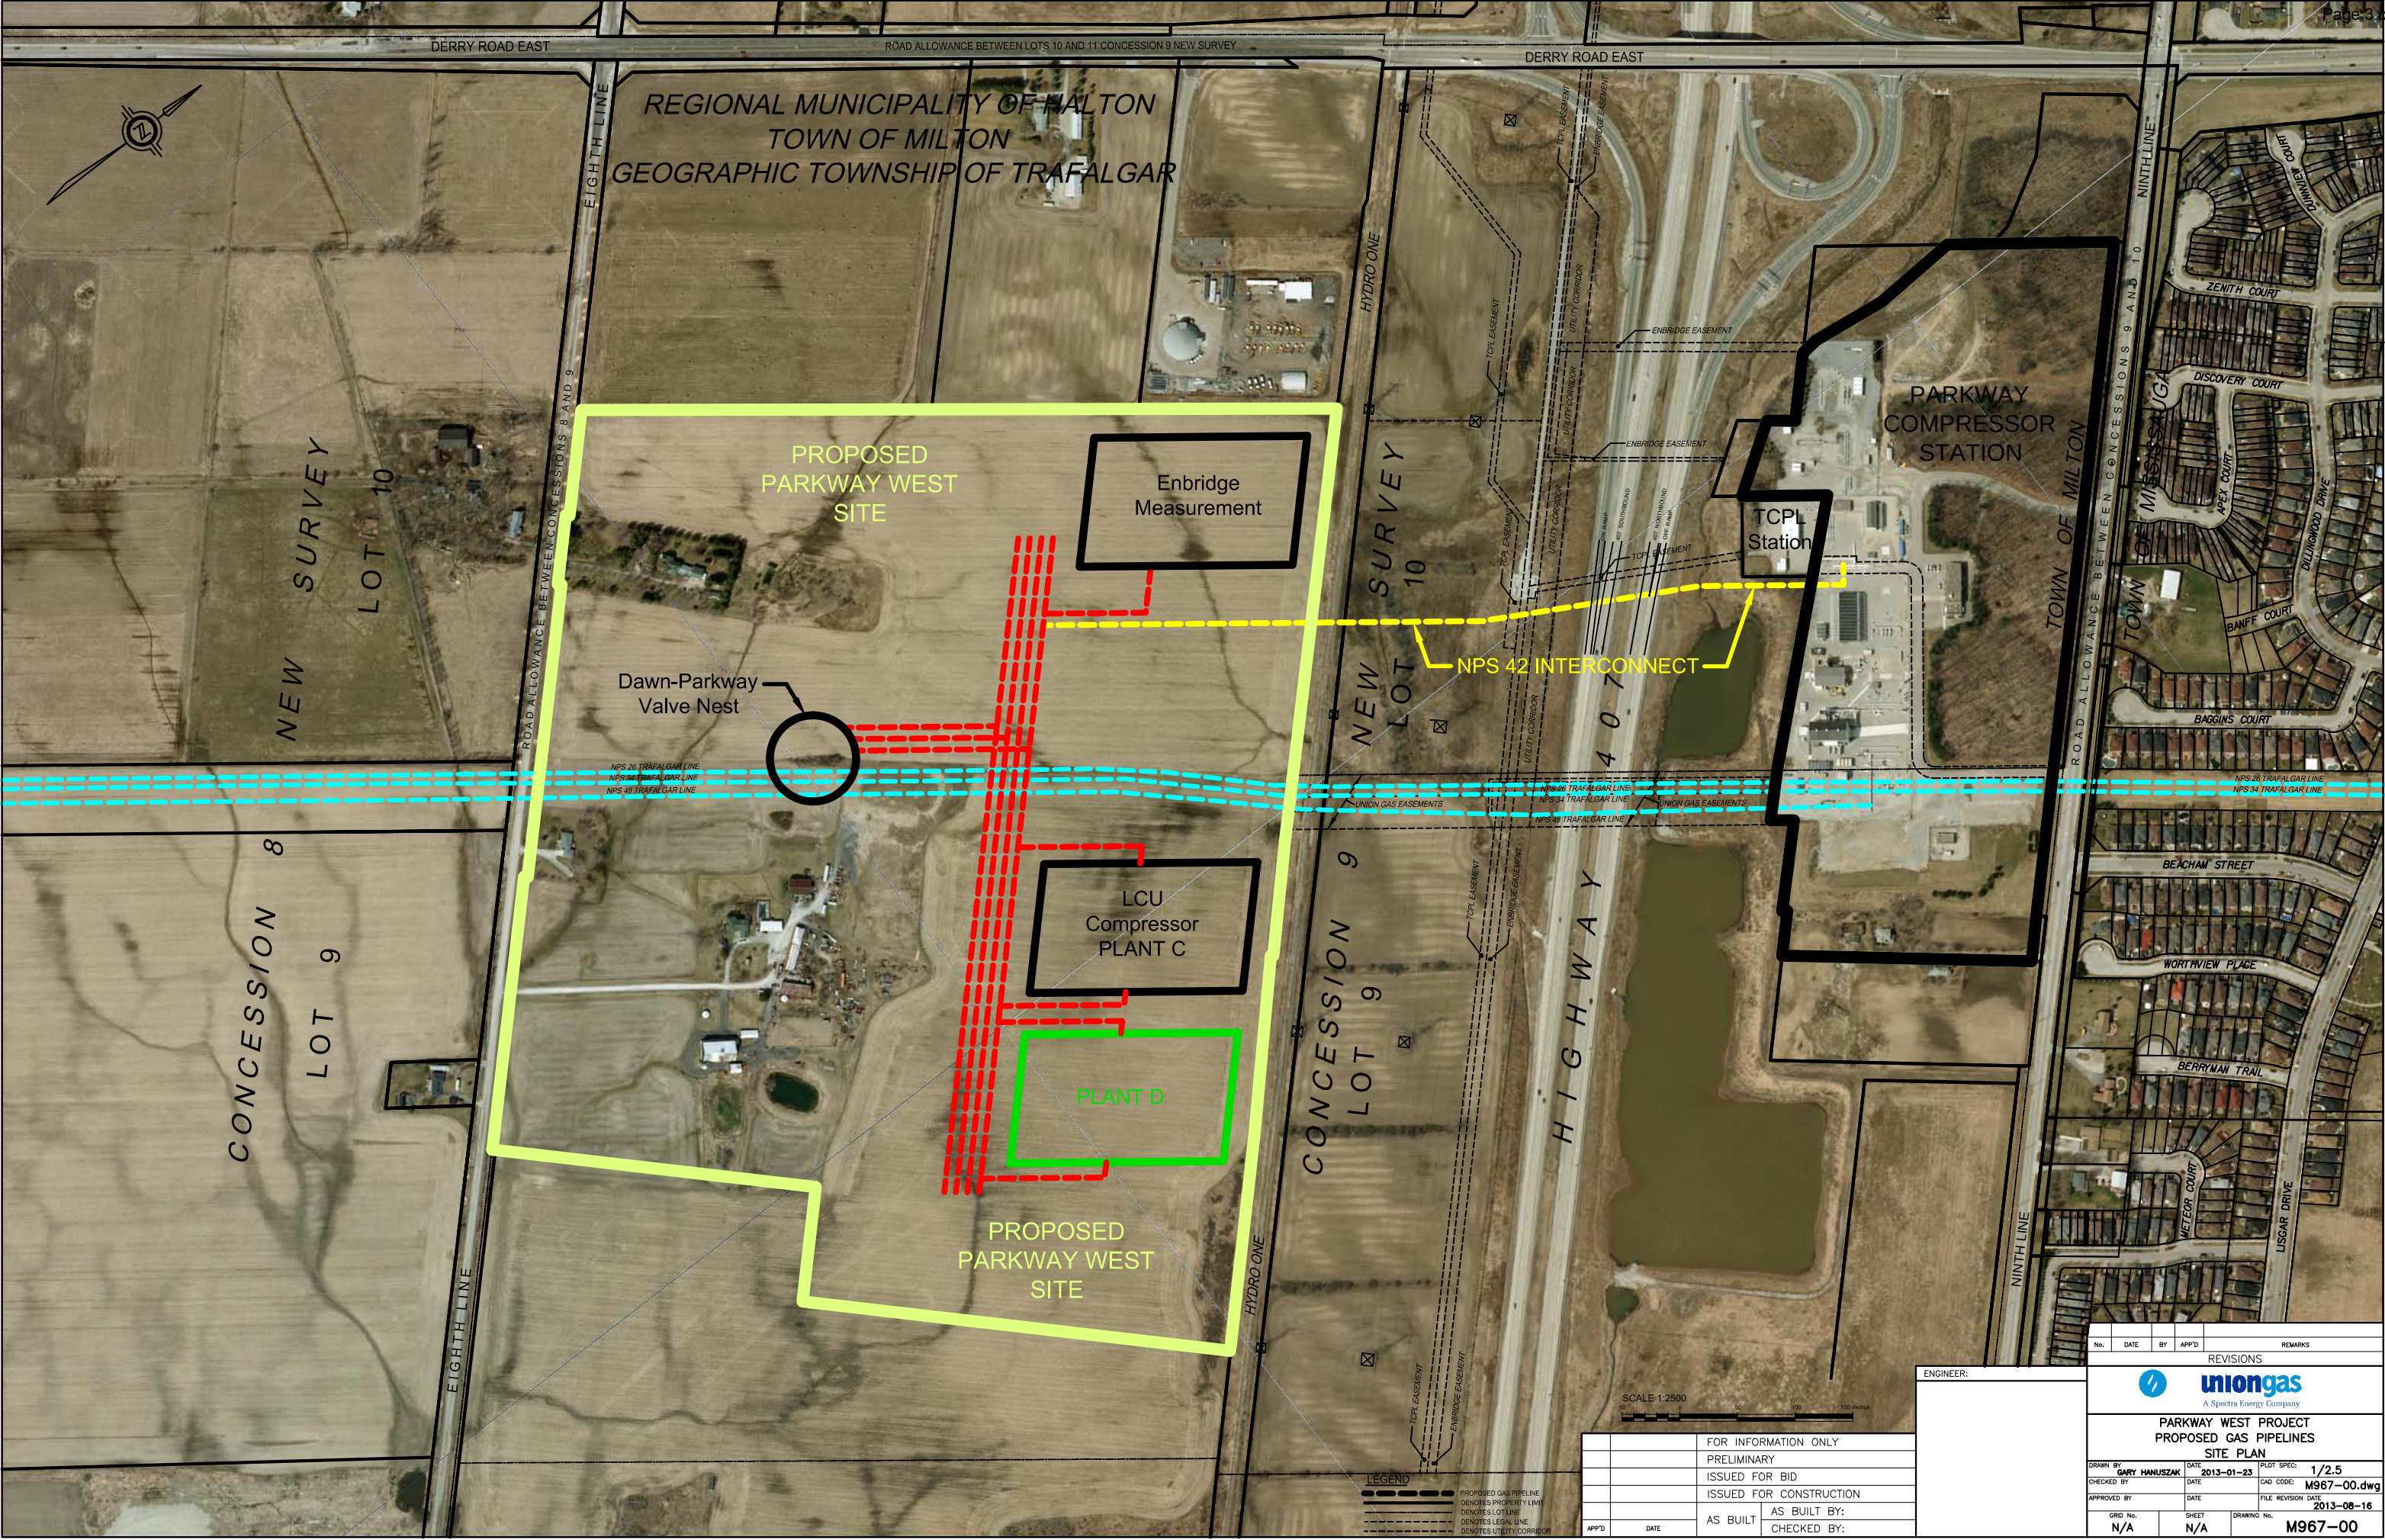

FOR INFORMATION ONLY	
PRELIMINARY	
ISSUED FOR BID	
ISSUED FOR CONSTRUCTION	
AS BUILT	AS BUILT BY:
APPROVED	CHECKED BY:

ENGINEER:			
REVISIONS			
No.	DATE	BY	APPROVED
REMARKS			
 A Spectra Energy Company			
PARKWAY WEST PROJECT PROPOSED GAS PIPELINES SITE PLAN			
DRAWN BY: GARY HANUSZAK	DATE: 2013-01-23	PLOT SPEC: 1/2.5	
CHECKED BY:	DATE:	CAD CODE: M967-00.dwg	
APPROVED BY:	DATE:	FILE REVISION DATE: 2013-08-16	
GRID No. N/A	SHEET N/A	DRAWING No. M967-00	